



PROJECT TEAM:

ARCHITECT:
BUELL KRATZER POWELL, P.C.
1525 LOCUST STREET
PHILADELPHIA, PA 19102
T: 215.557.6509

CIVIL ENGINEER:
CARROLL ENGINEERING, INC
215 SCHILLING CIRCLE, STE 102
HUNT VALLEY, MD 21031
T: 410.785.7423

LANDSCAPE ARCHITECT:
ROBINSON ANDERSON SUMMERS
28 WEST STATE STREET
MEDIA, PA 19063
T: 302.888.1544

STRUCTURAL ENGINEER:
STRUCTURAL DESIGN STUDIO, INC
2225 EAST MURRAY HOLLADAY RD
SALT LAKE CITY, UT 84117
T: 801.274.3950

MEP ENGINEER:
KOVACS, WHITNEY & ASSOCIATES
190 WEST OSTEND ST, STE 300
BALTIMORE, MD 21230
T: 410.244.7191

CLIENT:

MARYLAND ZOO
THE MARYLAND ZOO IN BALTIMORE
1 SAFARI PLACE
BALTIMORE, MD 21217

RED PANDA
THE MARYLAND ZOO
IN BALTIMORE
1 SAFARI PLACE
BALTIMORE, MD 21217


THIS DRAWING IS TO ILLUSTRATE THE WORK TO BE DONE. THE ARCHITECT IS NOT RESPONSIBLE FOR THE MEANS, METHODS, TECHNIQUES, SEQUENCES AND PROCEDURES USED TO DO THE WORK OR THE SAFETY ASPECTS OF CONSTRUCTION, AND NOTHING ON THIS DRAWING EXPRESSED OR IMPLIED CHANGES THIS CONDITION. CONTRACTOR SHALL BE RESPONSIBLE FOR DETERMINING HOW THEY AFFECT THE WORK. SUBMITTAL OF A BID TO PERFORM THIS WORK IS AN ACKNOWLEDGMENT OF THESE RESPONSIBILITIES, AND THAT THEY HAVE BEEN FULLY CONSIDERED IN PLANNING OF THE WORK, AND THE BID PRICE. NO CLAIMS FOR EXTRA CHARGES DUE TO THESE CONDITIONS WILL BE FORTHCOMING.

SEAL:


DATE:	JANUARY 14, 2025
PROJECT NO:	2023-10.04
DRAWN BY:	KWA
CHECKED BY:	KWA
SUBMISSION:	DATE
BID SET:	01/14/2025
REVISION:	DATE
ADDENDUM # 1:	02/03/2025

DRAWING TITLE:
PIPING SCHEMATICS

DRAWING NO:
P-601

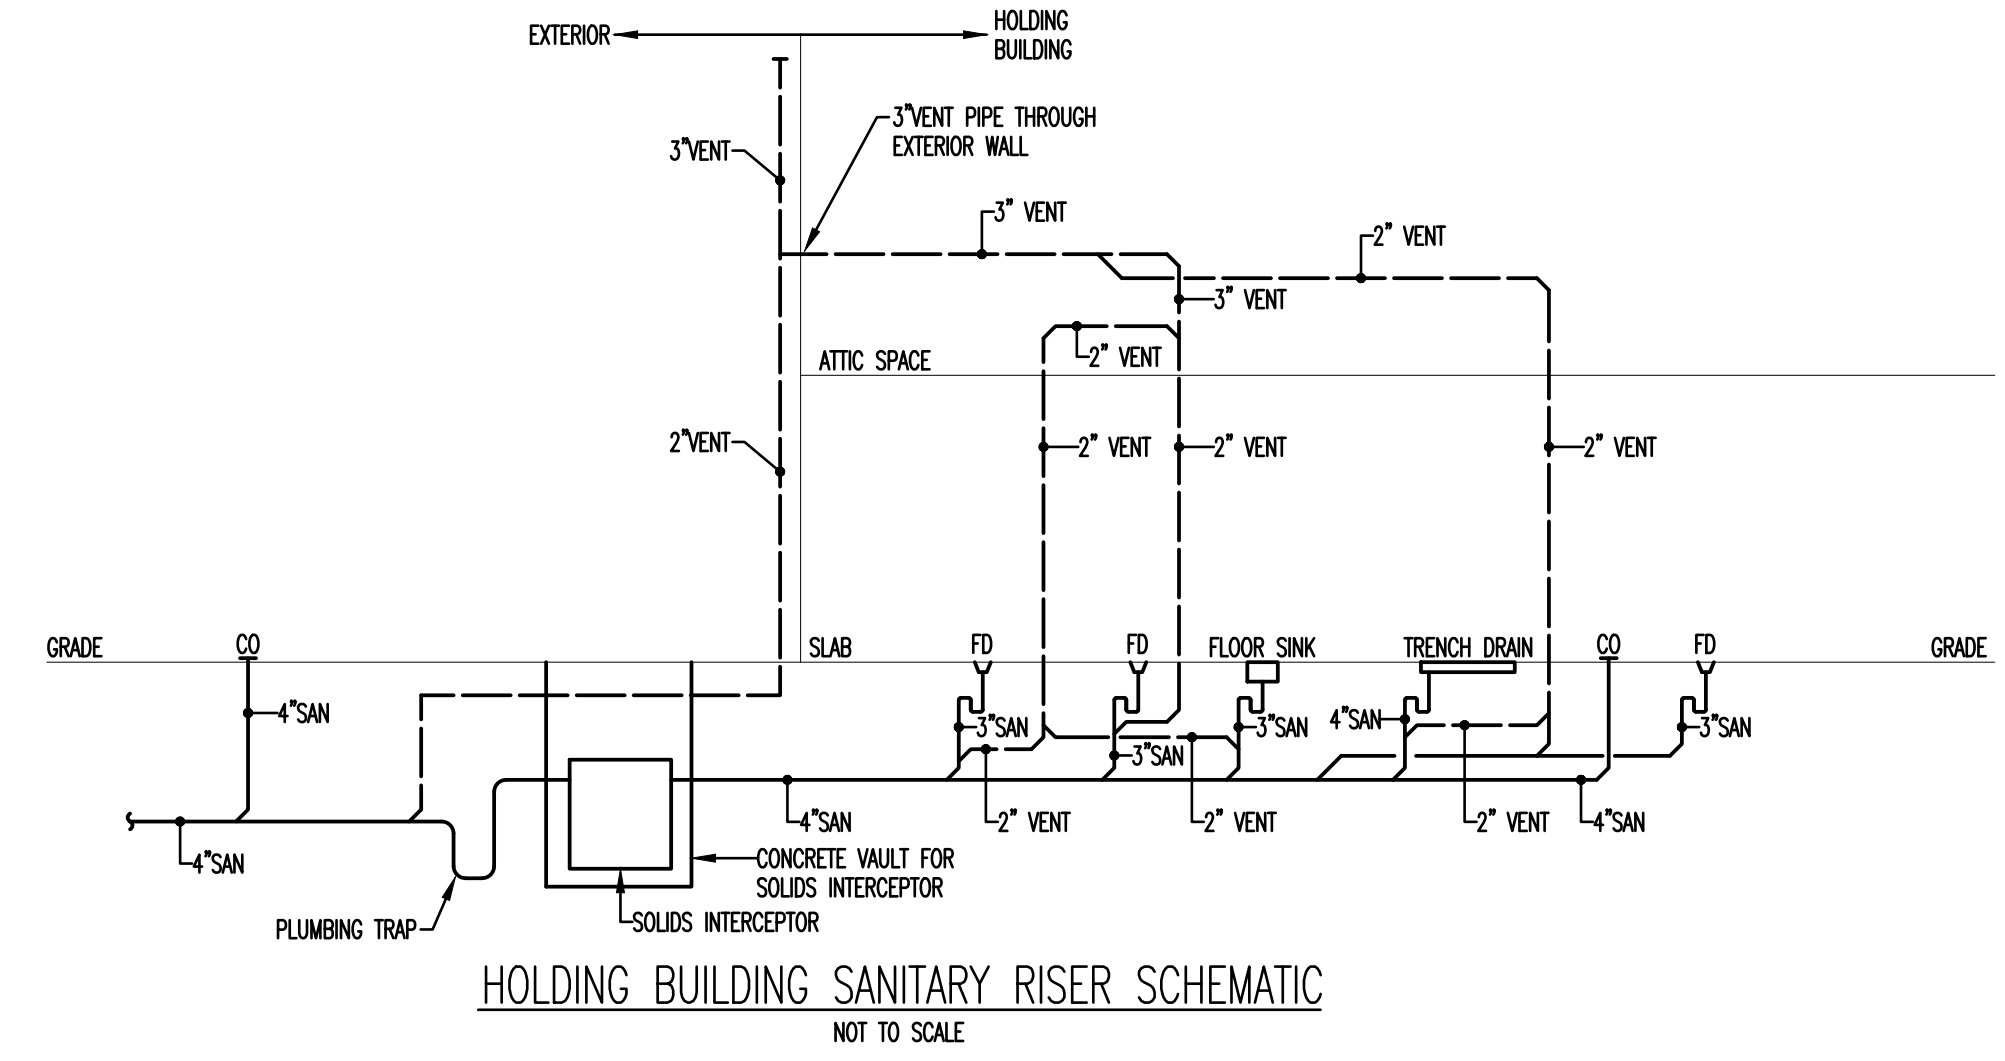

HOLDING BUILDING SANITARY RISER SCHEMATIC
NOT TO SCALE

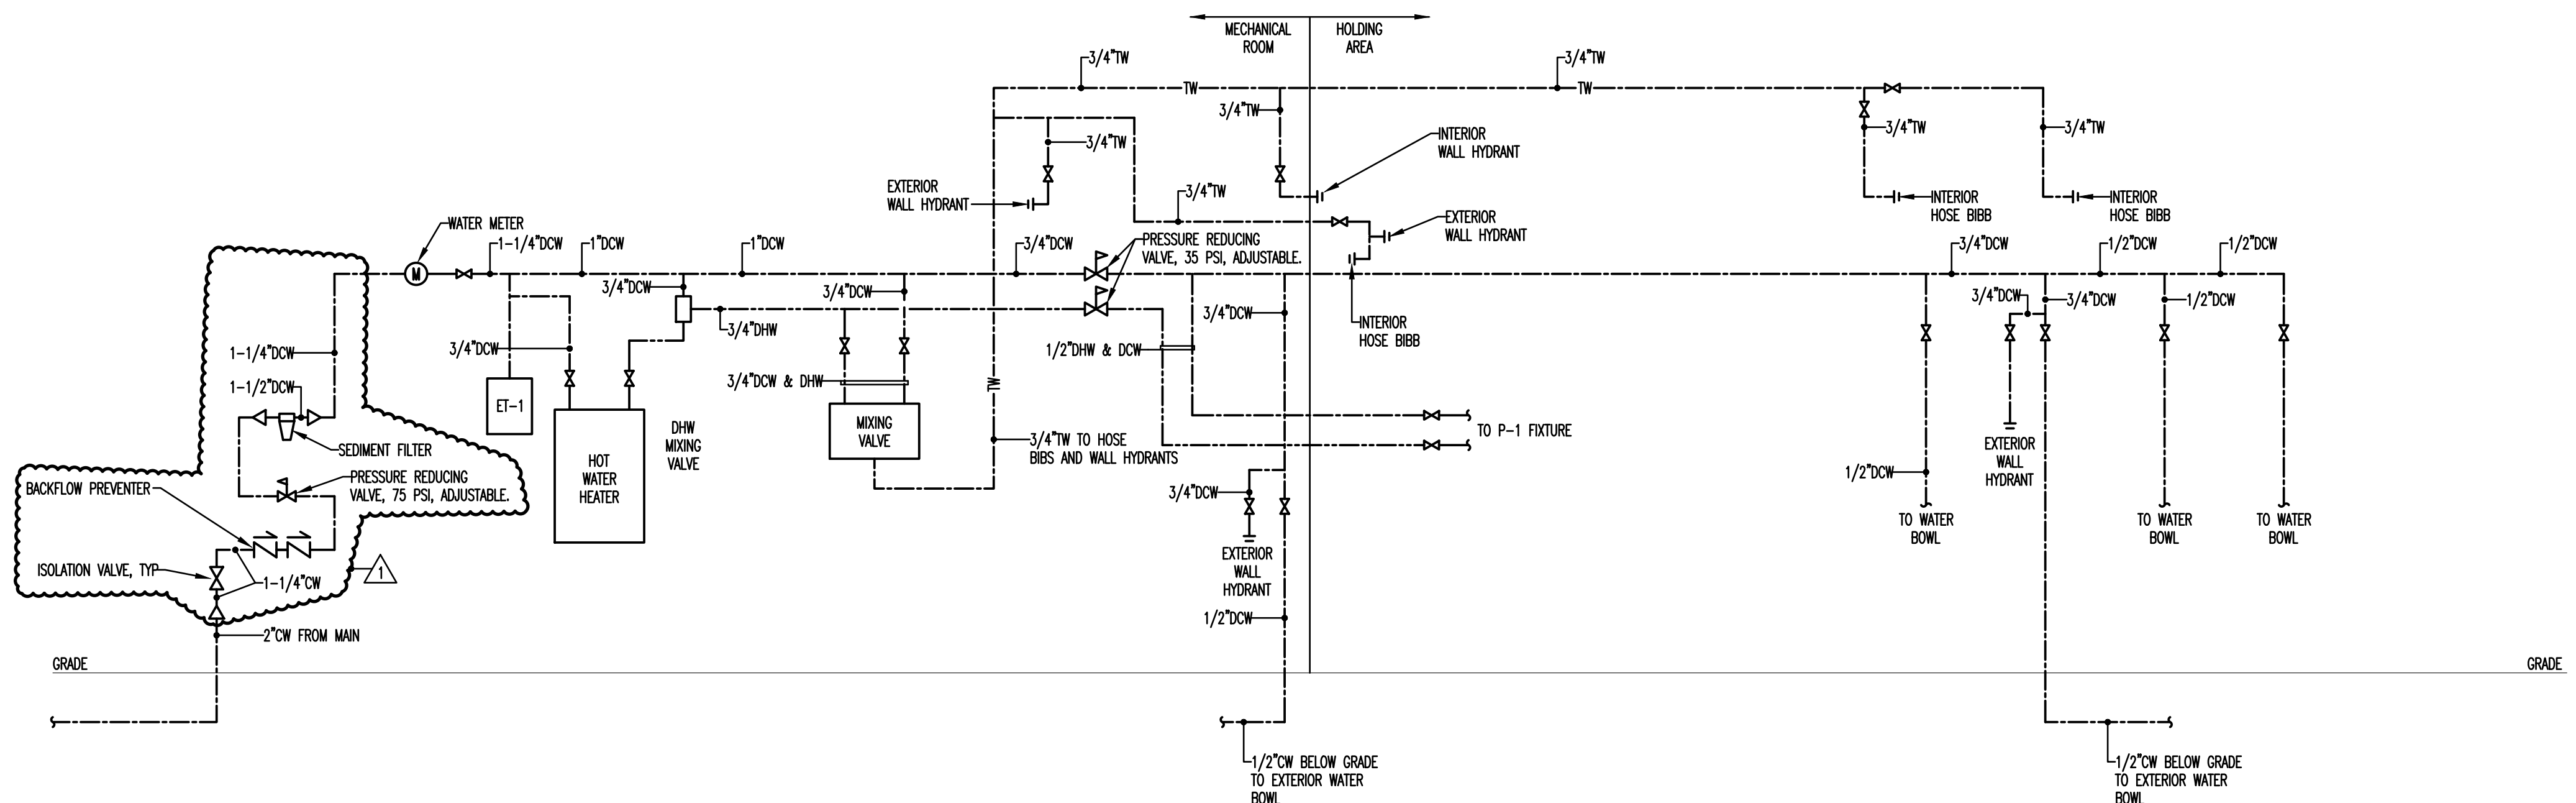

HOLDING BUILDING DOMESTIC WATER SCHEMATIC
NOT TO SCALE

Q
P
N
M
L
K
J
H
G
F
E
D
C
B
A

1 2 3 4 5 6 7 8 9 10 11 12 13 14 15 16 17 18 19 20

10877 - RED PANDA